


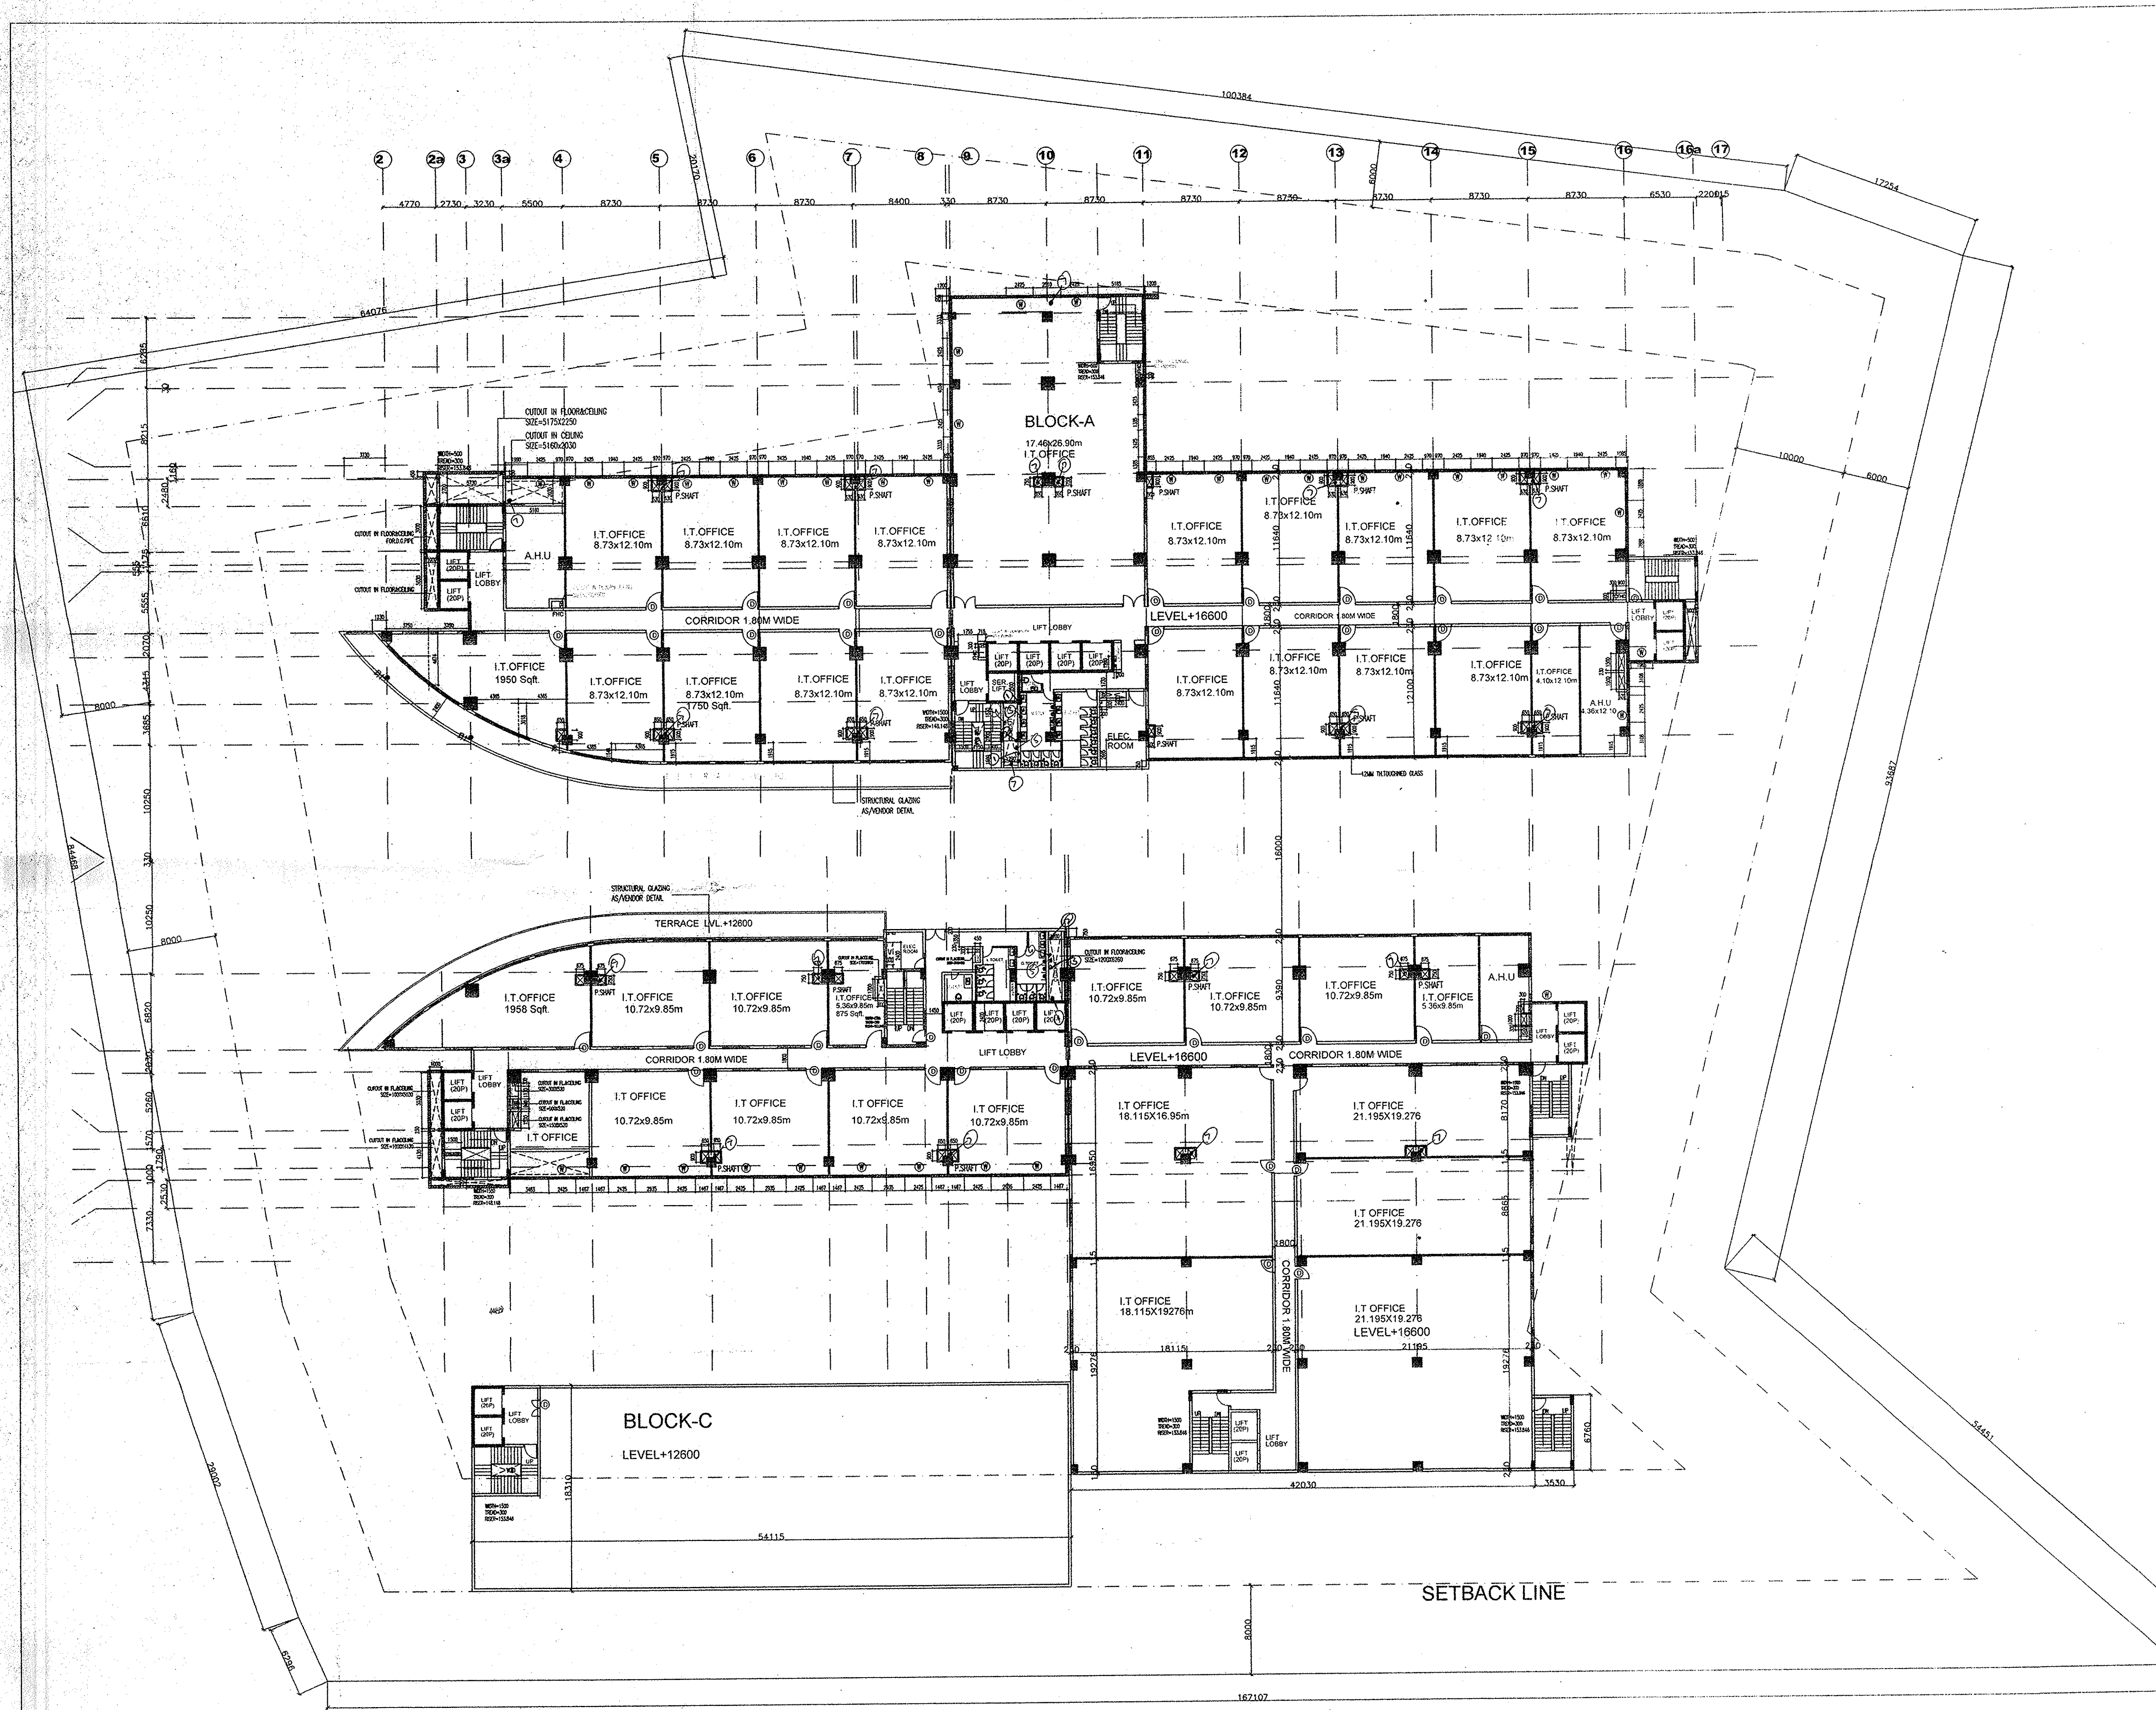

NOTES:

1. BUILDING IS ARTIFICIALLY LIGHTED, MECHANICALLY VENTILATED, FULLY AIRCONDITIONED & HAS AUTOMATIC SPRINKLER SYSTEM ON ALL FLOORS

[Signature]
D.T.P.(Hr.)
Member Secretary
B.P.C.

[Signature]
S.T.P.(F)
Member B.P.C.

[Signature]
C.T.P.(Hr.)
Chairman B.P.C.

To be read in conjunction with
memo No. *[Handwritten]* dtd. *[Handwritten]*

SCHEDULE OF DOORS & WINDOWS

D1=2000X2700
D2=900X2100
D3=900X2700
D4= 750X2100
DW1=3828X2700
DW2=6527X2700
DW3=6115X2700
DW4=5163X2700

OWNERS SEAL & SIGNATURE

[Signature]
For DOVE INFRASTRUCTURE PVT. LTD.
Auth. Sign.

ARCHITECTS SEAL & SIGNATURE

[Signature]
PPADIPRA SRIJANA
CA 91/2004

PROJECT TITLE: *[Blank]* Check and found ok for
Public & Internal Services
Comments in
forw. No. *[Handwritten]* Dt. *[Handwritten]*
92 (Hr) / 201

PROJECT: I.T PARK MEASURING 8.5 ACES IN REVENUE ESTATE OF VILLAGE ANANGPUR, TEHSIL AND DISTRICT FARIDABAD, HARYANA. BELONGS TO M/S.DOVE INFRASTRUCTURE PVT.LTD. Engineer (Hr.)
HUDA, Faridabad

FOR: M/S.DOVE INFRASTRUCTURE PVT.LTD.

DRAWING TITLE:
SECOND FLOOR PLAN
LEVEL+16600

DATE: APRIL-2010 DRAWING NO. *[Blank]*

SCALE: 1:200 10 *[North Arrow]*